
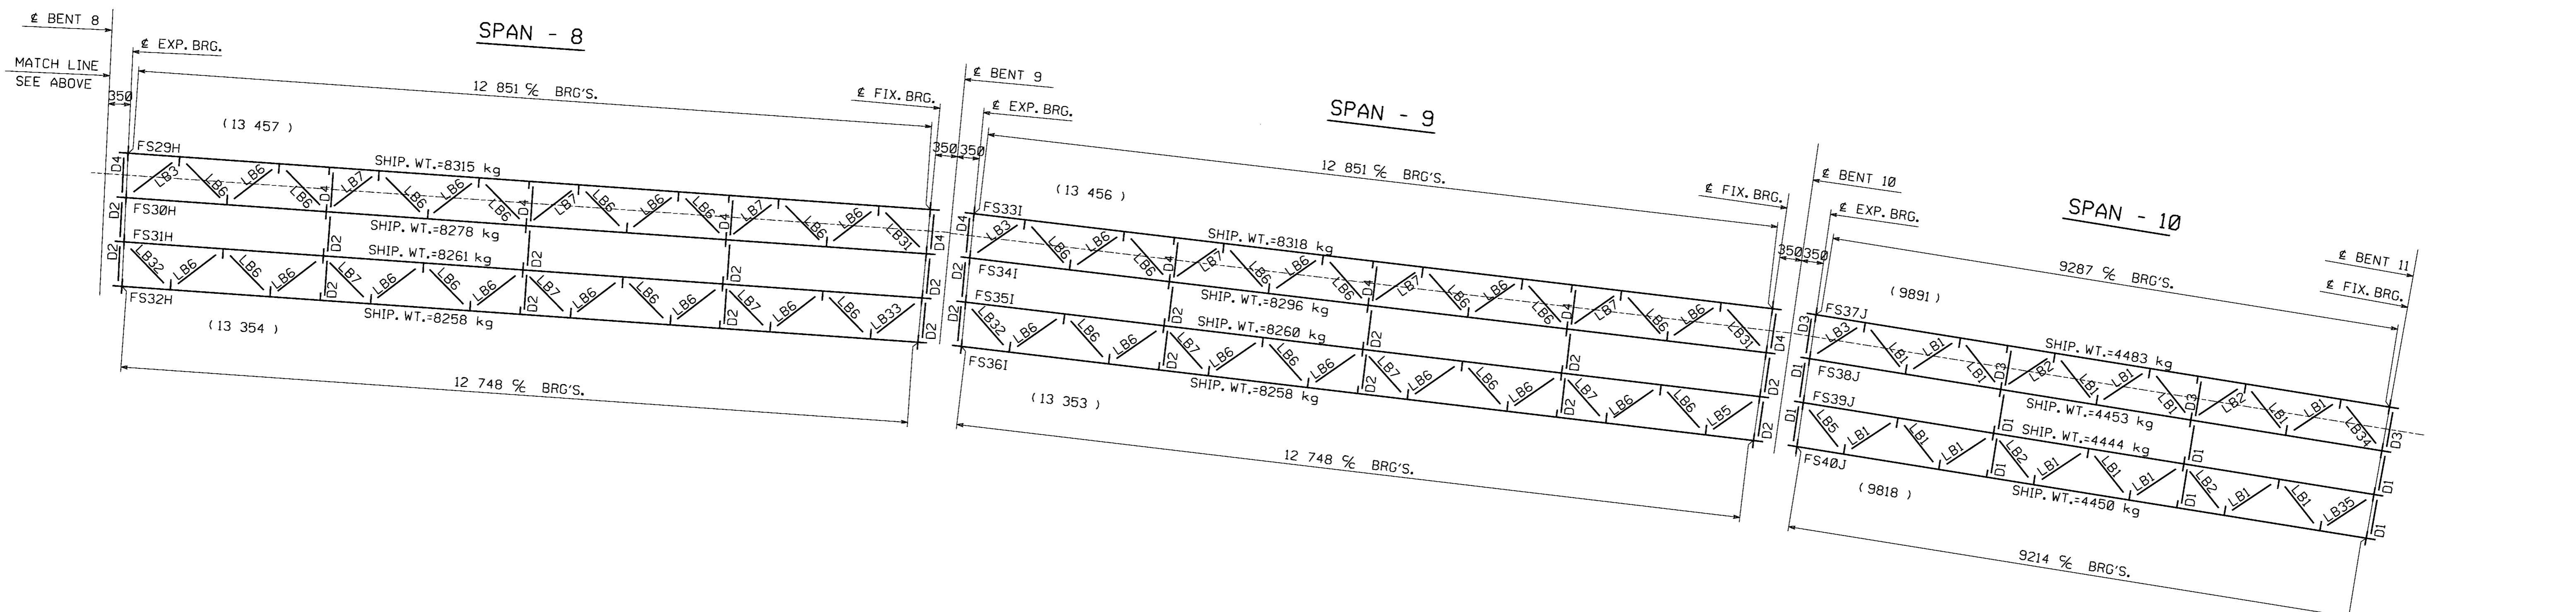


METRIC

METRIC


1. ALL DIMENSIONS ARE IN MILLIMETERS UNLESS OTHERWISE NOTED.
2. ALL WEIGHTS ARE IN KILOGRAMS.

FED. ROAD DIV. NO.	STATE	FED. AID PROJ. NO.
3	PA	

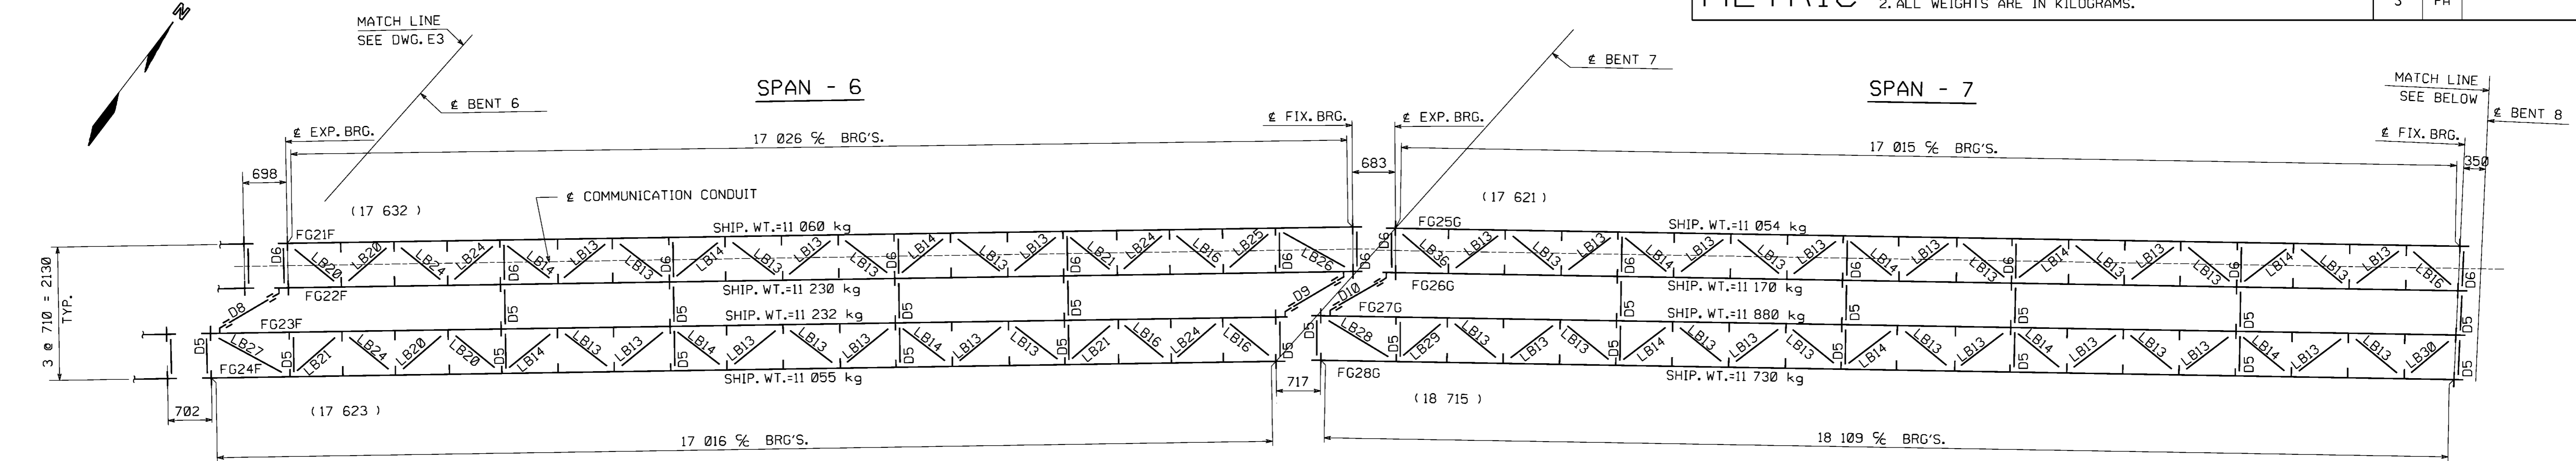

ERECTION FRAMING PLAN

FOR GENERAL NOTES SEE DWG. E3.
WORK THIS DWG. WITH DWG. E3.

NO.	REVISION	BY	DATE
 1770 Hempstead Road Lancaster, PA 17605-0008 Phone 717/299-5211 A Division of High Industries, Inc.			
ERECTION FRAMING PLAN			
N.S. RAILWAY TEMP. TRESTLE BRIDGE OVER S.R. 0309			
N.S. RAILWAY TEMP. TRESTLE BRIDGE STA. 8 + 671.276			
MONTGOMERY COUNTY, PA			
COMMONWEALTH OF PENNSYLVANIA			
DEPARTMENT OF TRANSPORTATION			
STATE CONTRACT OR REF. NO.	S-25417	ECMS NO. 64275	
CONTRACTOR	NYLEVE BRIDGE CORPORATION		
IN CHARGE:	COLONIAL(WRC)	MADE BY: RAS	CHK'D BY: JTC DATE: 12-9-04
CONTRACT NUMBER:	PA-04091-1	DRAWING NUMBER:	E4 OF E4

BY: c:n1
PLOTTED: 03/23/05 03:55:29 PM